




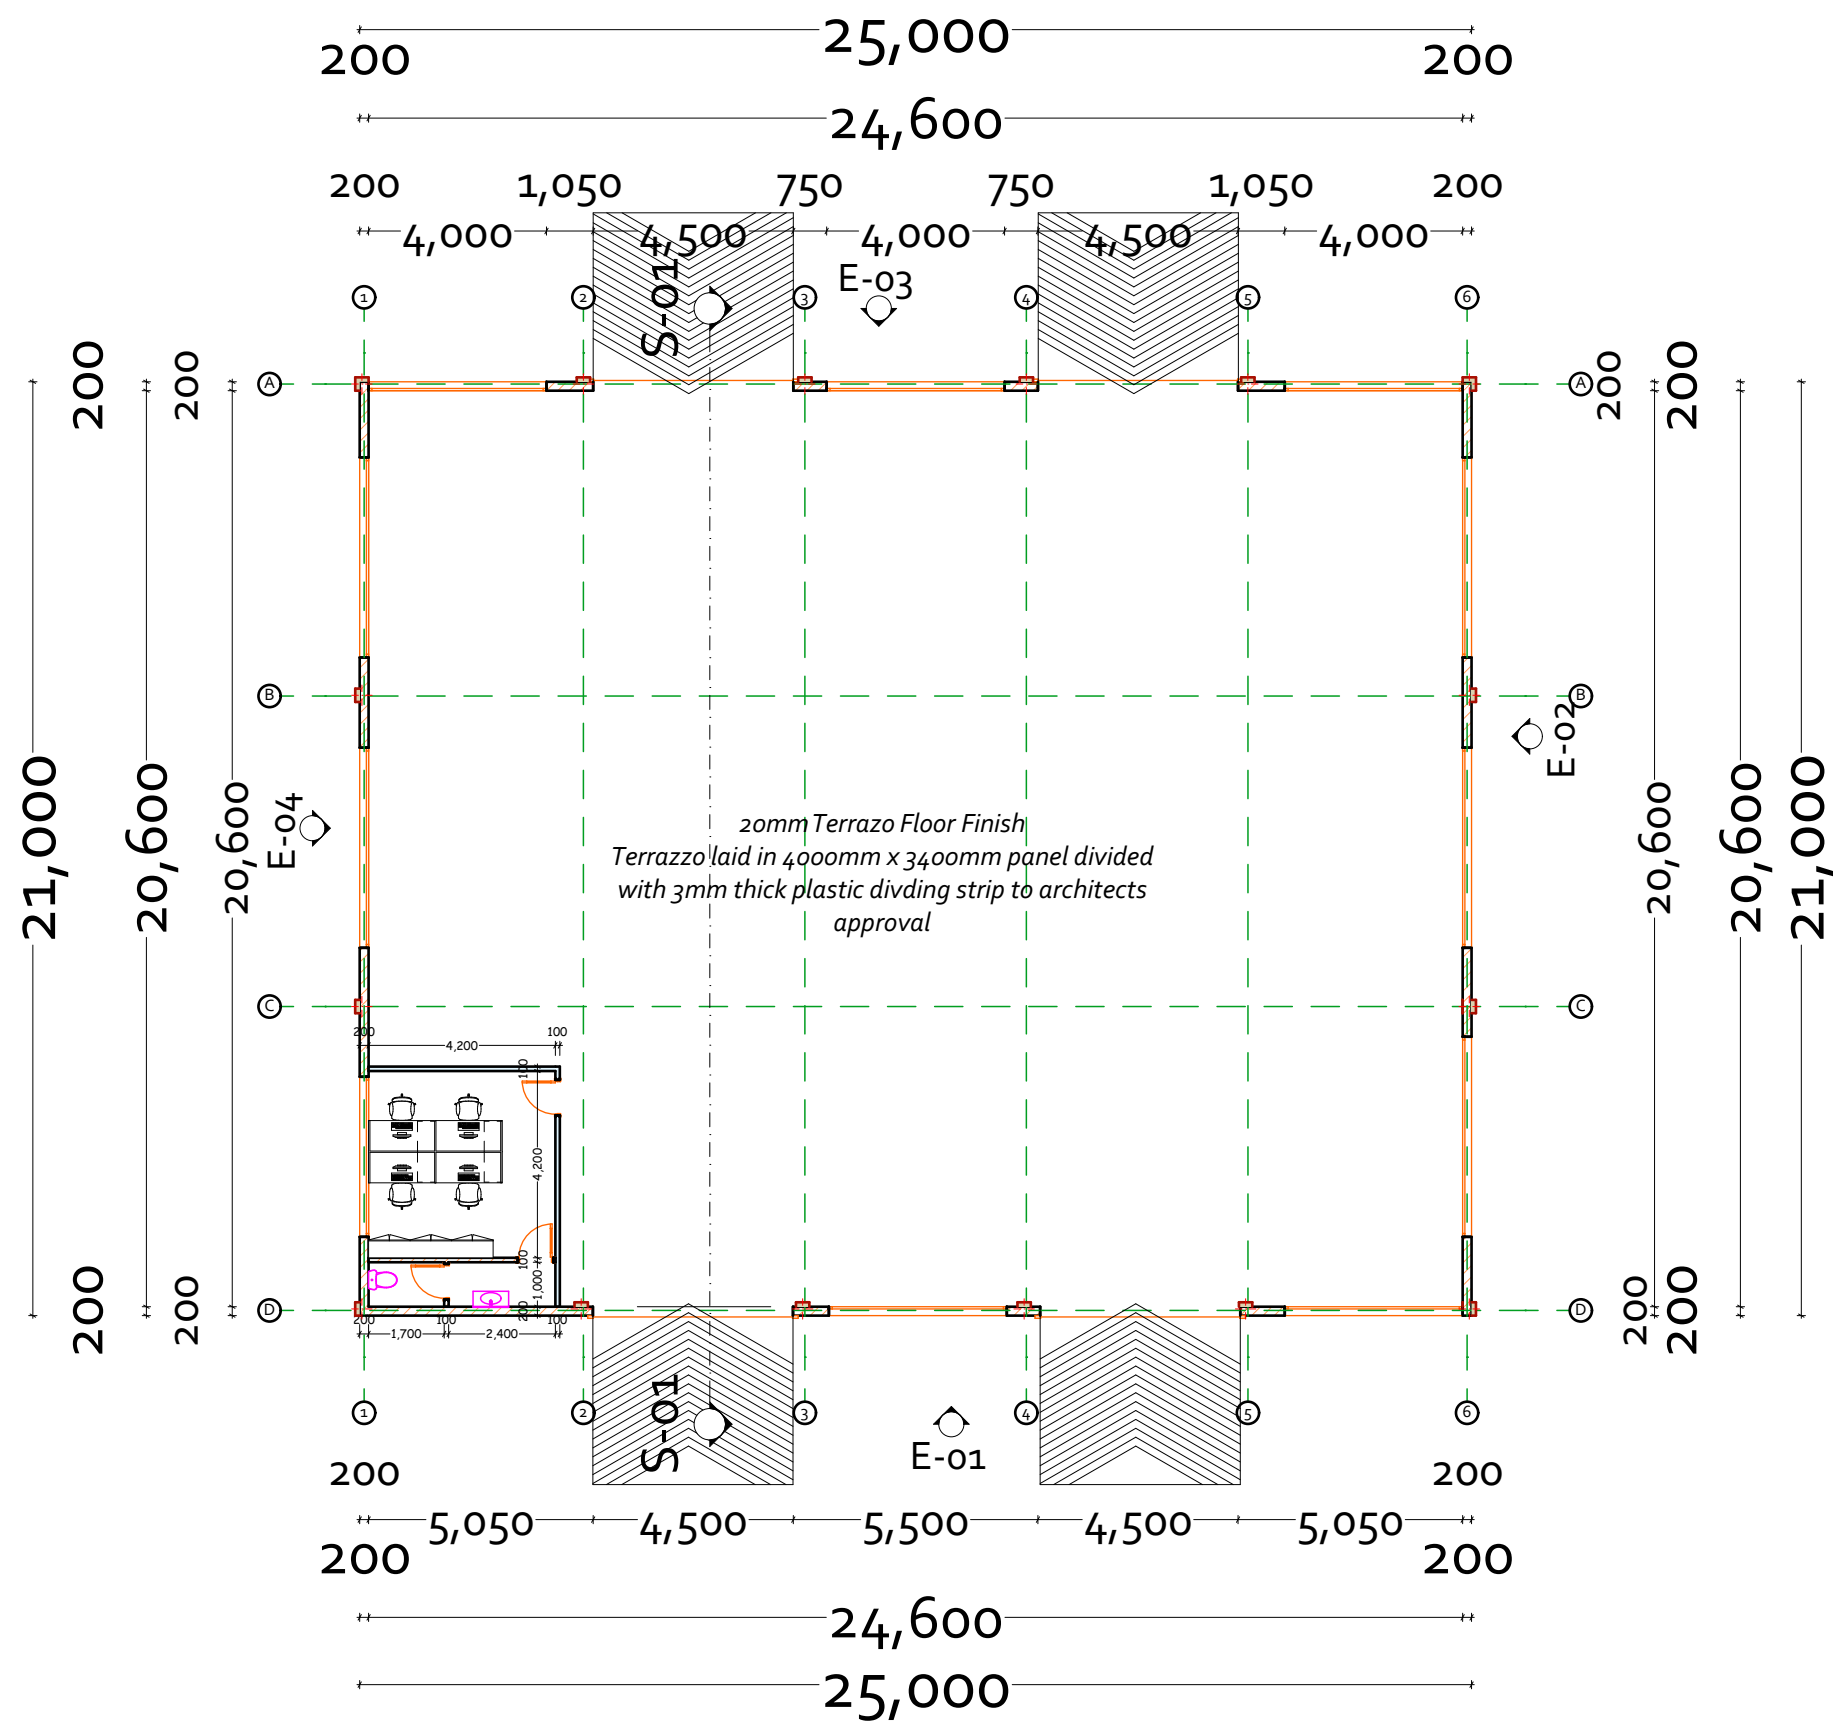


FLOOR PLAN
SCALE 1:100

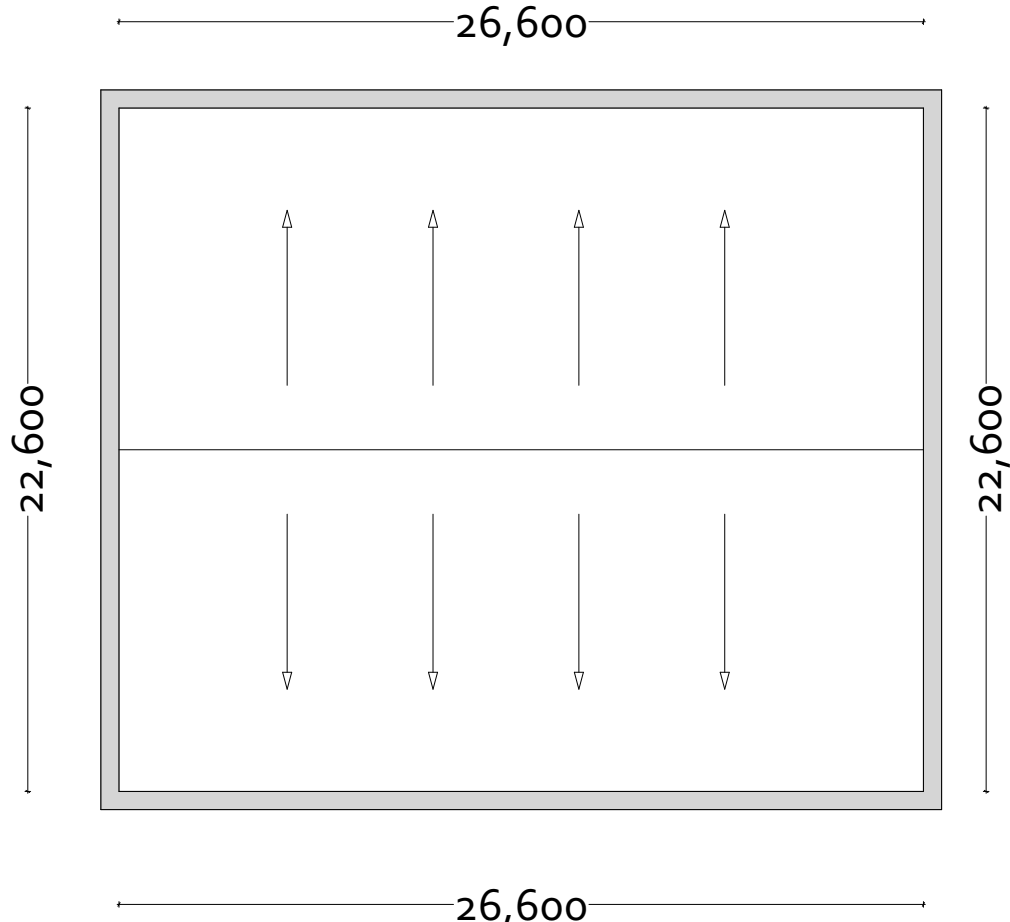


ROOF PLAN
SCALE 1:150

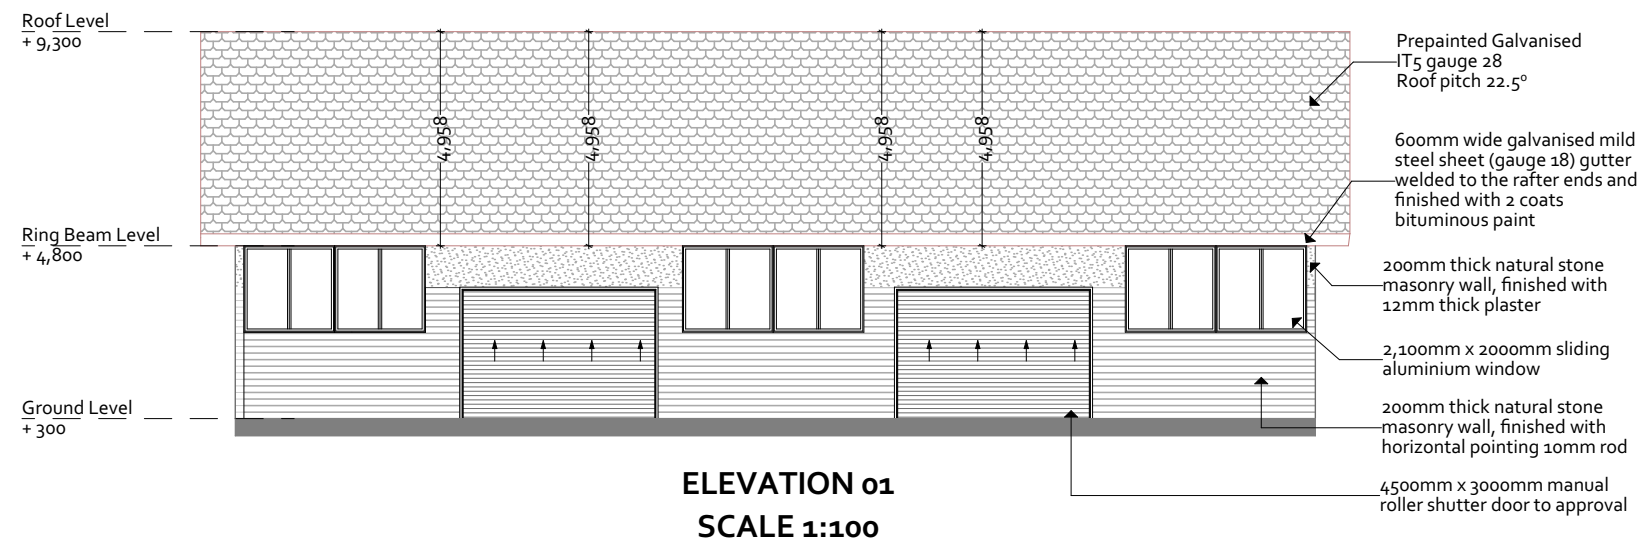


ELEVATION 01
SCALE 1:100

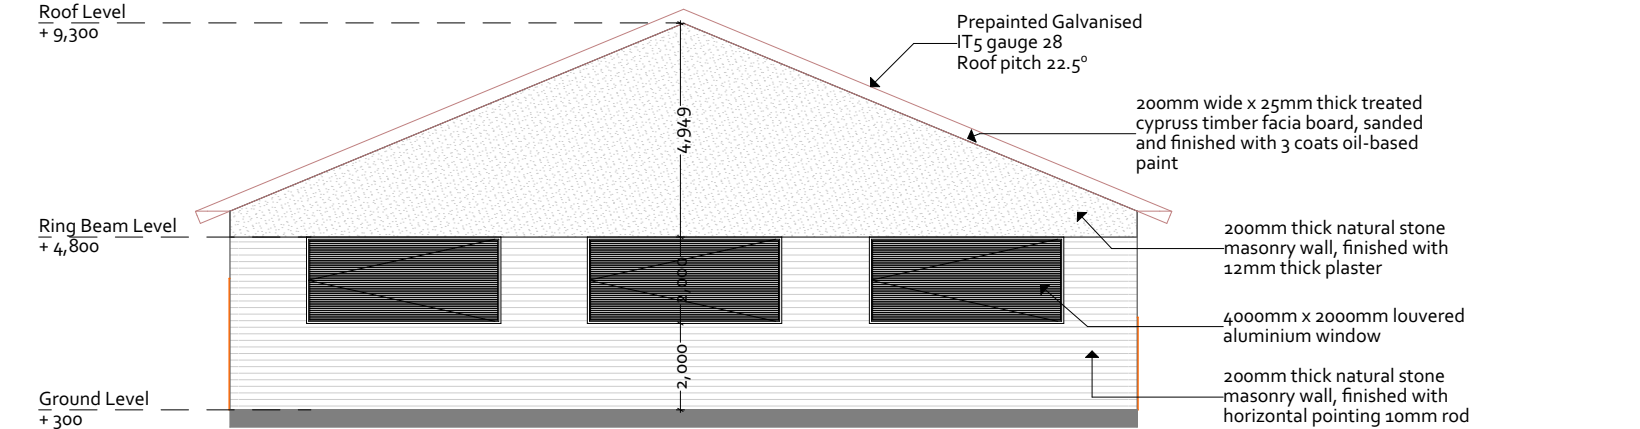


ELEVATION 02
SCALE 1:100

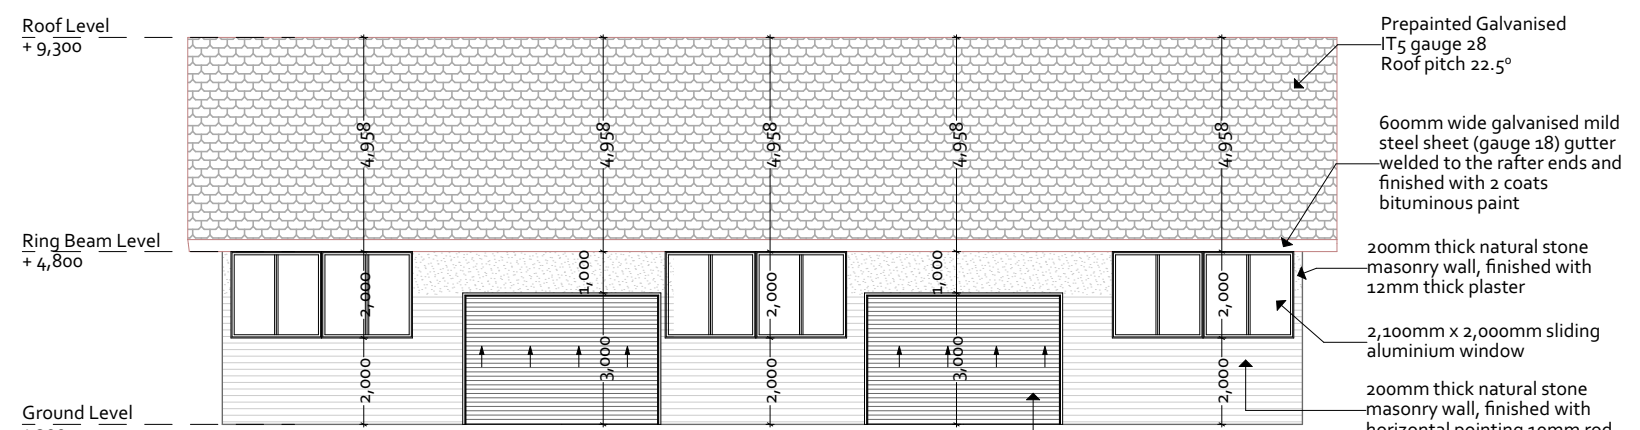

ELEVATION 03
SCALE 1:100

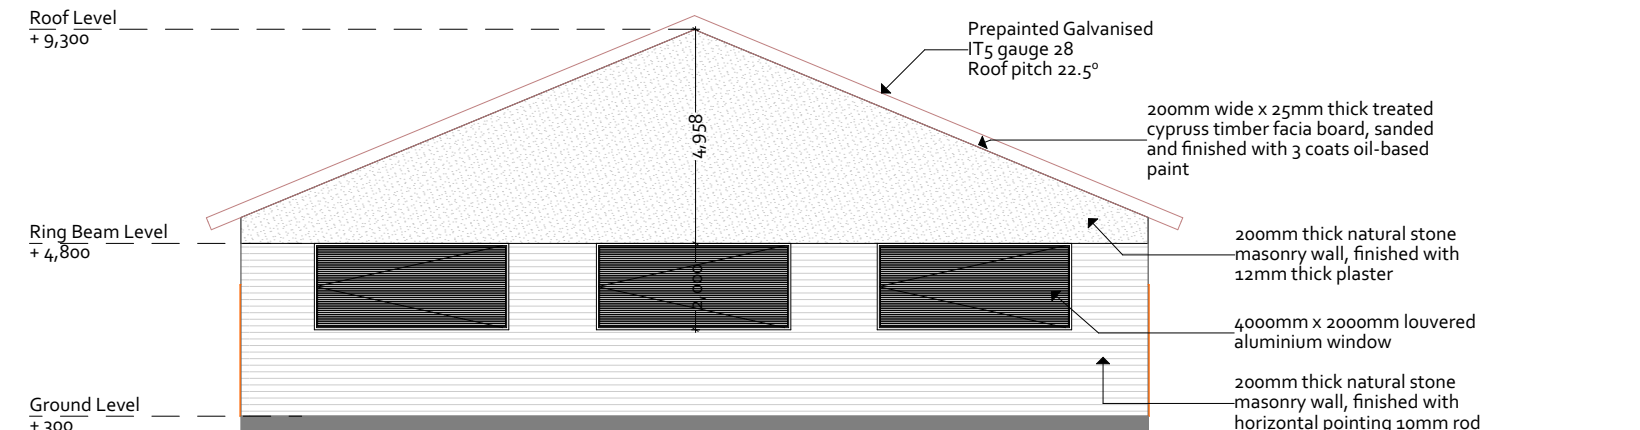

ELEVATION 04
SCALE 1:100

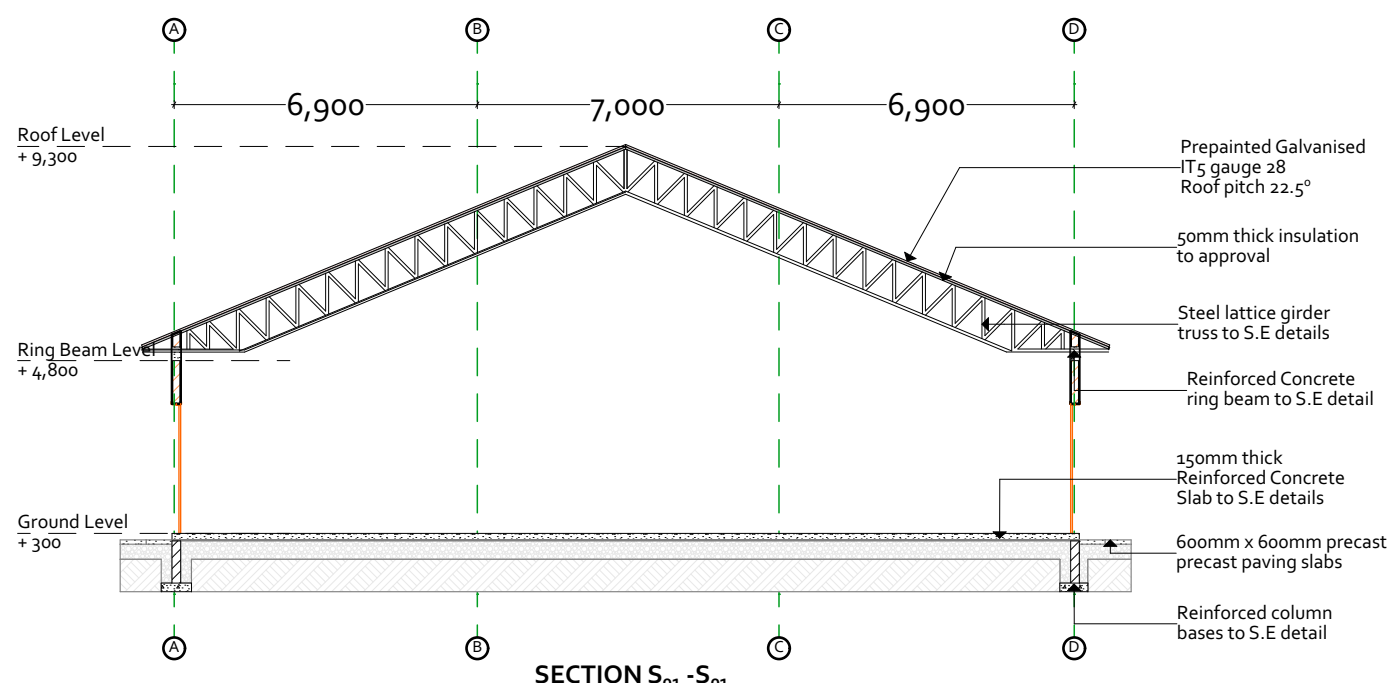

SECTION S₀₁-S₀₁

NOTES

GENERAL

1. All dimensions in mm

2.No scaling of drawing. Contractor to check all dimensions and setting out and confirm with architect and or engineer as necessary.

3. Any discrepancy should be notified immediately to the designer and clarified by consulting the respective consultants' drawings.

4. Permanent vents (pv) to be provided to all windows and doors except wc doors.

STRUCTURAL

9. All RC works to be in accordance to engineer's detail.

MECHANICAL

11. All plumbing and drainage to comply with MoPW's specification.

12. All service ducts to be accessible from all floors.

14. Deep seal or anti-vac to all fittings connected to the SVP's or waste pipes.

15. All bends and junctions to have inspection plates

16. Drain pipes passing beneath buildings and driveways to be encased in 150mm concert surround

17.All underground foul and waste drain pipes shall be cast iron to comply to BS41514 and 5225.

ELECTRICAL

26.All Electrical works must be co-ordinated with mechanical works.

27. Any conflicts must be clarified before work

Revisions

Project

COMPLETION OF PROPOSED STORAGE FACILITIES FOR (RERC) AT KISUMU

Drawing title

GO DOWN/ WAREHOUSE KSM-002

CLIENT

RURAL ELECTRIFICATION & RENEWABLE ENERGY CORPORATION (RERC)

Client signature

Scale

1:100

1:150

Project job no.

WP ITEM NO. D1152 NY/KSM/2202 JOB NO. 111388

Drawn & Designed

Arch. Wacuka T.W.

May, 2024

Checked

Arch. J.K. Manyiri

May, 2024

APPROVED

Arch. L.M.Mochama

B.Arch (HONS) M.A.A.K(A)

CHIEF ARCHITECT

STATE DEPARTMENT FOR PUBLIC WORKS

ARCHITECTURAL DEPARTMENT

FOR THE GOVERNMENT OF THE REPUBLIC OF KENYA